

PROJECT

PROPOSED DRGS. OF DEMONSTRATION HOUSING PROJECT
 (Use: OLD AGE HOME) AT CHIMBEL, GOA

DRG. TITLE		NORTH
LAYOUT PLAN		
DATE	SCALE	
DEC. 2019		
DEALT BY	APP. BY	

COPYRIGHT:
 THIS DRAWING IS PROTECTED UNDER COPYRIGHT.
 NOT TO BE REPRODUCED OR COPIED TO A THIRD
 PARTY OR USED FOR ANY PURPOSE OTHER THAN
 THE PROJECT TO WHICH ISSUED WITHOUT THE
 KNOWLEDGE AND CONSENT OF THE DESIGN OFFICE

NOTES:
 * ALL DIMENSIONS ARE IN MM
 * ALL LEVELS ARE IN MM

AREA DETAIL		
Area of Plot	= 50.0 x 40.0	=2000 Sqmts.
Covered Area on Ground Floor		= 985.5Sqmts
Covered Area on First Floor		= 968.7sqmts
Total Covered Area		=1954.2 sqmts =21027.2 sqfts

bmtgc

BUILDING MATERIALS & TECHNOLOGY PROMOTION COUNCIL
 MINISTRY OF HOUSING & URBAN AFFAIRS, (Govt. of India)
 CORE-5A, 1st. FLOOR, INDIA HABITAT CENTRE,
 LODHI ROAD, NEW DELHI - 110003
 PHONE-011-24638096, 011-24638097. Website: www.bmtgc.org.

DRG. NO. **2019/DHP/GA/OH/AR-01**

DRG. FOR APPROVAL TENDER CONSTRUCTION

COPYRIGHT:
THIS DRAWING IS PROTECTED UNDER COPYRIGHT.
NOT TO BE REPRODUCED OR COPIED TO A THIRD
PARTY OR USED FOR ANY PURPOSE OTHER THAN
THE PROJECT TO WHICH ISSUED WITHOUT THE
KNOWLEDGE AND CONSENT OF THE DESIGN OFFICE


NOTES:
* ALL DIMENSIONS ARE IN MM
* ALL LEVELS ARE IN MM

Sl. No.	TYPE	SIZE	CHL. LVL.	INT. LVL.	REMARK
1	SD1	1500X2550	-	2550	SWING DOOR
2	D1	1200X2100	-	2100	Typ. Door
3	D2	1000X2100	-	2100	Room
4	D3	900X2100	-	2100	Toilet
5	D3	750X2100	-	2100	Toilet
6	W1	1200X1650	900	2550	Typical (Gr.Ft)
7	W2	1350X1650	900	2550	Typical
8	W3	1200X1550	1000	2550	Partry
9	W5	600X1050	1500	2550	Toilet
10	D4	900X2100	-	2100	MSDoor

Note:
All level are from finished floor level.

AREA DETAIL

Area on Ground Floor = 985.5 sqms
Area on First Floor = 968.7 sqms

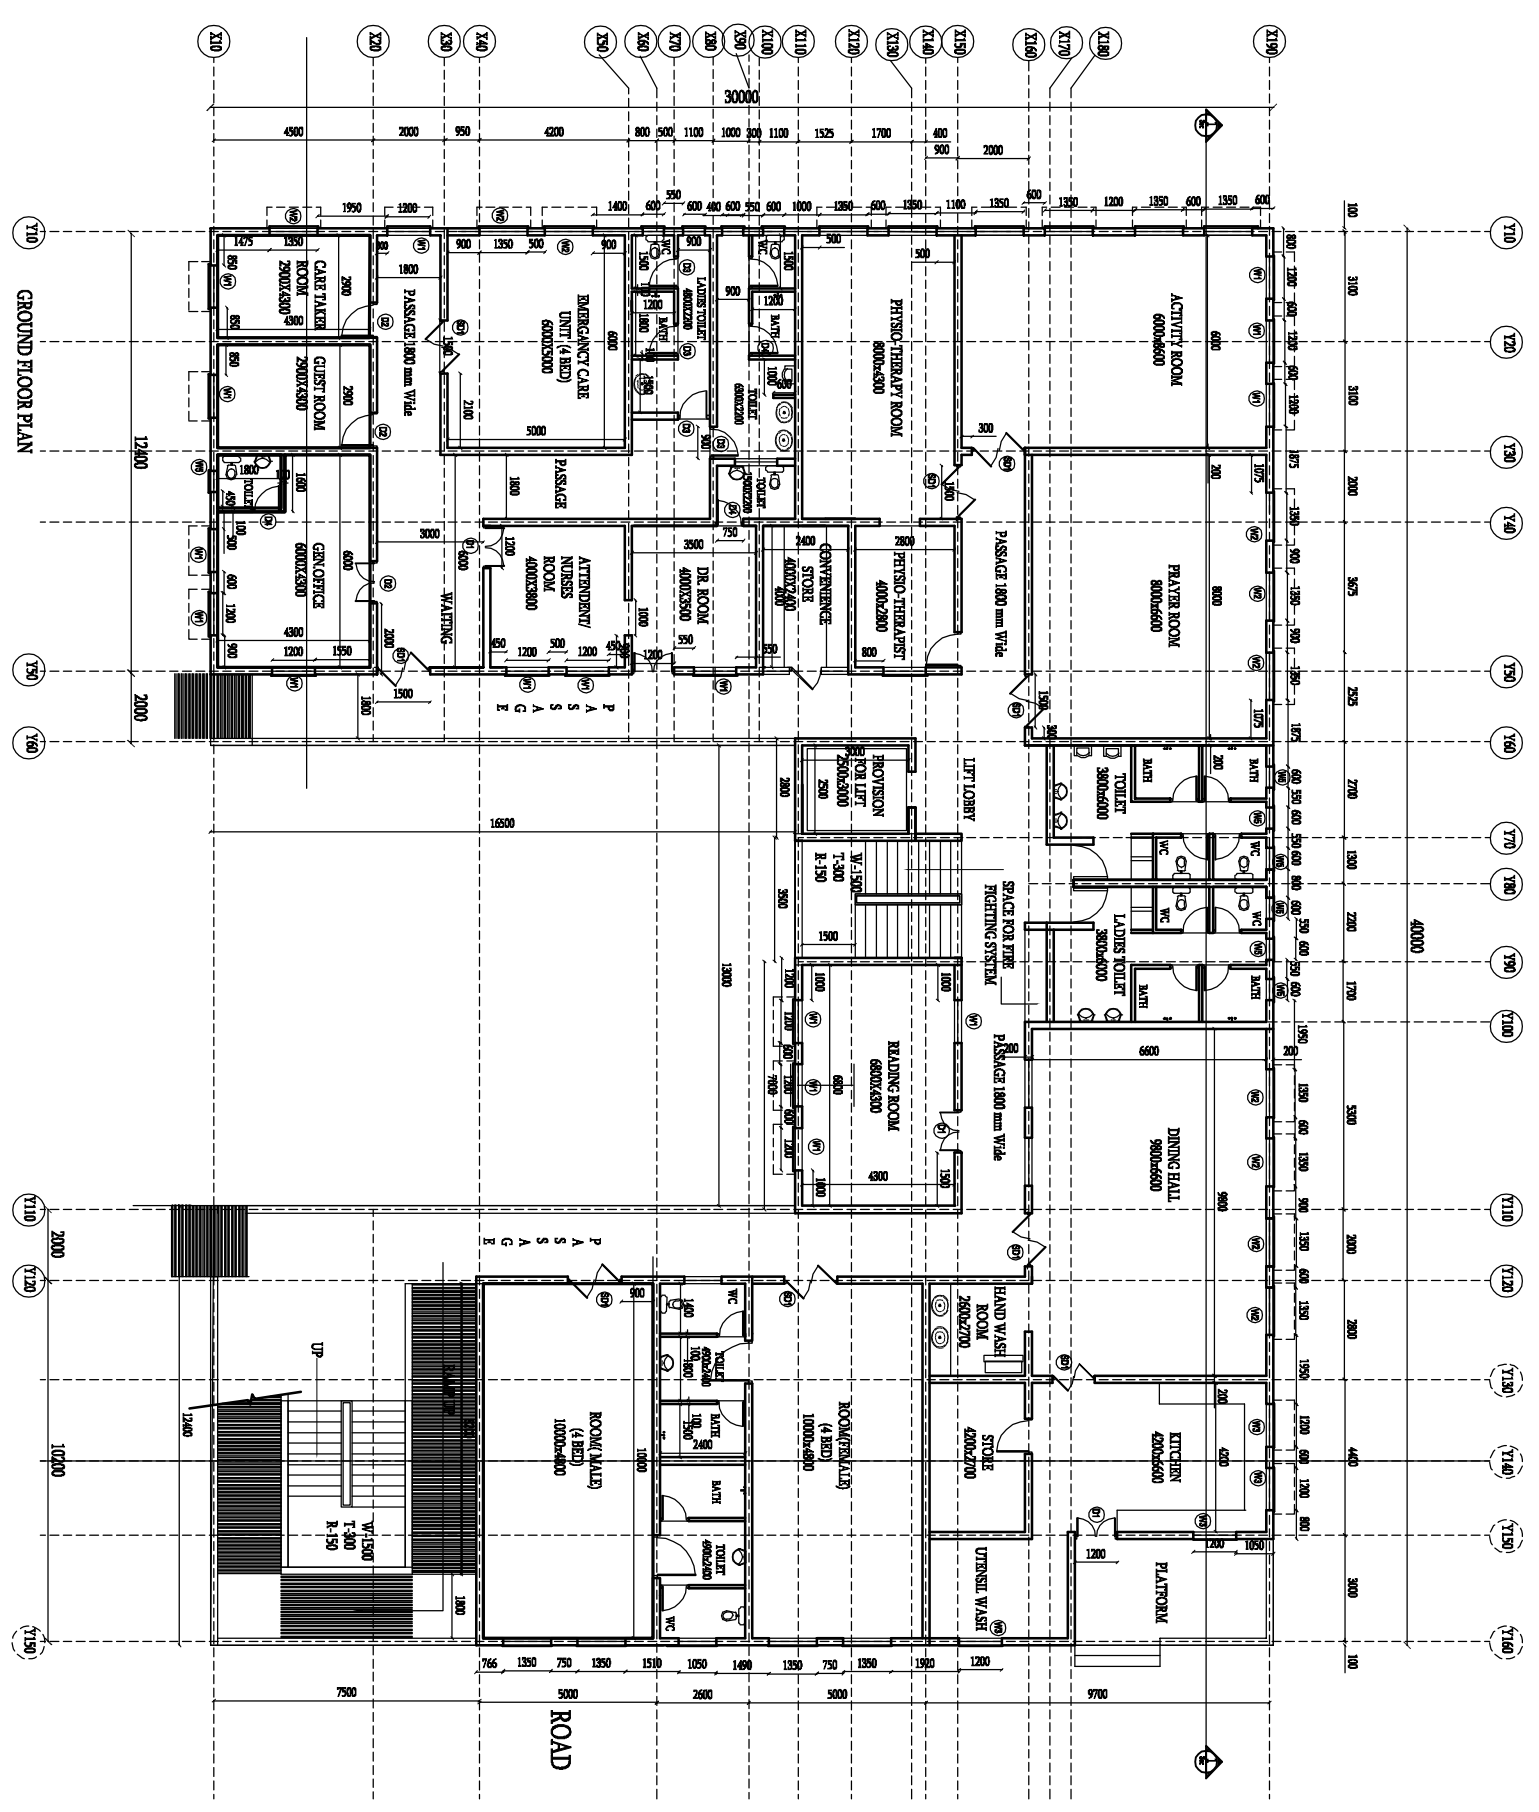

GROUND FLOOR PLAN

PROJECT

PROPOSED DRGS. OF DEMONSTRATION HOUSING PROJECT
(Use: OLD AGE HOME) AT CHIMBEL, GOA

GROUND FLOOR PLAN

DRG. TITLE

DATE: DEC. 2019
SCALE: NORTH

DEALT BY: APP. BY




BUILDING MATERIALS & TECHNOLOGY PROMOTION COUNCIL
MINISTRY OF HOUSING & URBAN AFFAIRS, (Govt. of India)
CORE-5A, 1st FLOOR, INDIA HABITAT CENTRE,
LODHI ROAD, NEW DELHI - 110003
PHONE-011-24638096, 011-24638097. Website: www.bhpgc.org.

DRG. NO. 2019/DHP/GA/OH/AR-02

DRG. FOR APPROVAL TENDER CONSTRUCTION

COPYRIGHT:
 THIS DRAWING IS PROTECTED UNDER COPYRIGHT,
 NOT TO BE REPRODUCED OR COPIED TO A THIRD
 PARTY OR USED FOR ANY PURPOSE OTHER THAN
 THE PROJECT TO WHICH ISSUED WITHOUT THE
 KNOWLEDGE AND CONSENT OF THE DESIGN OFFICE

NOTES:
 * ALL DIMENSIONS ARE IN MM
 * ALL LEVELS ARE IN MM

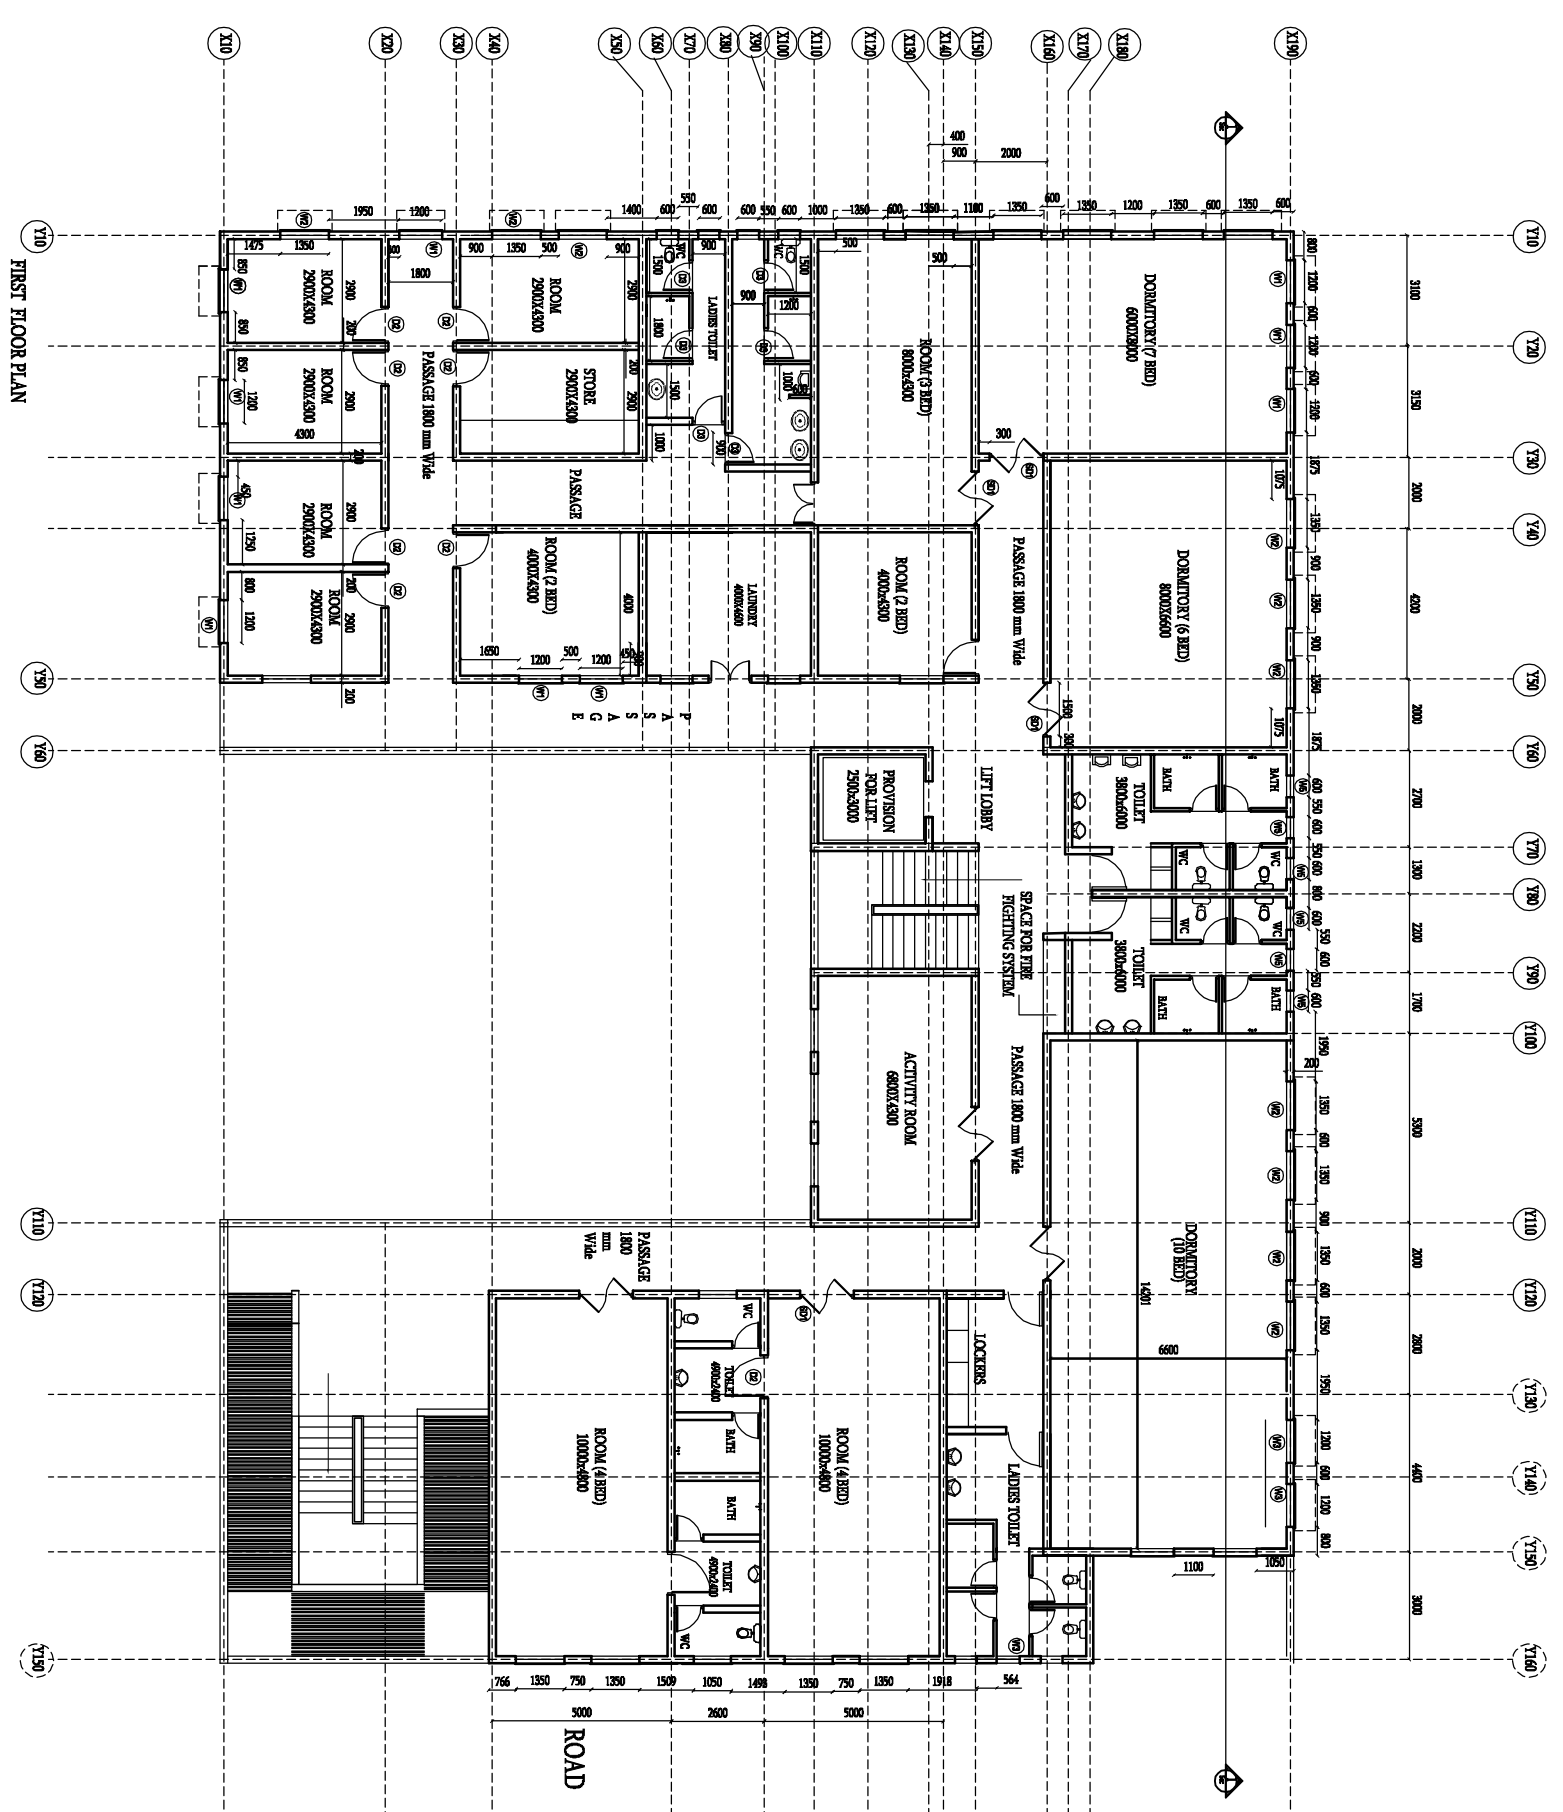

PROJECT

PROPOSED DRGS. OF DEMONSTRATION HOUSING PROJECT
 (Use: OLD AGE HOME) AT CHIMBEL, GOA

DRG. TITLE		FIRST FLOOR PLAN	
DATE	SCALE	NORTH	
DEC. 2019			
DEALT BY	APP. BY		


DMPC
 BUILDING MATERIALS & TECHNOLOGY PROMOTION COUNCIL
 MINISTRY OF HOUSING & URBAN AFFAIRS, (Govt. of India)
 CORE-5A, 1st FLOOR, INDIA HABITAT CENTRE,
 LODHI ROAD, NEW DELHI - 110003
 PHONE-011-24638096, 011-24638097. Website: www.dmtpc.org.

DRG. NO. **2019/DHP/GA/OH/AR-03**

DRG. FOR APPROVAL TENDER CONSTRUCTION

COPYRIGHT:
THIS DRAWING IS PROTECTED UNDER COPYRIGHT.
NOT TO BE REPRODUCED OR COPIED TO A THIRD
PARTY OR USED FOR ANY PURPOSE OTHER THAN
THE PROJECT TO WHICH ISSUED WITHOUT THE
KNOWLEDGE AND CONSENT OF THE DESIGN OFFICE

NOTES:
* ALL DIMENSIONS ARE IN MM
* ALL LEVELS ARE IN MM

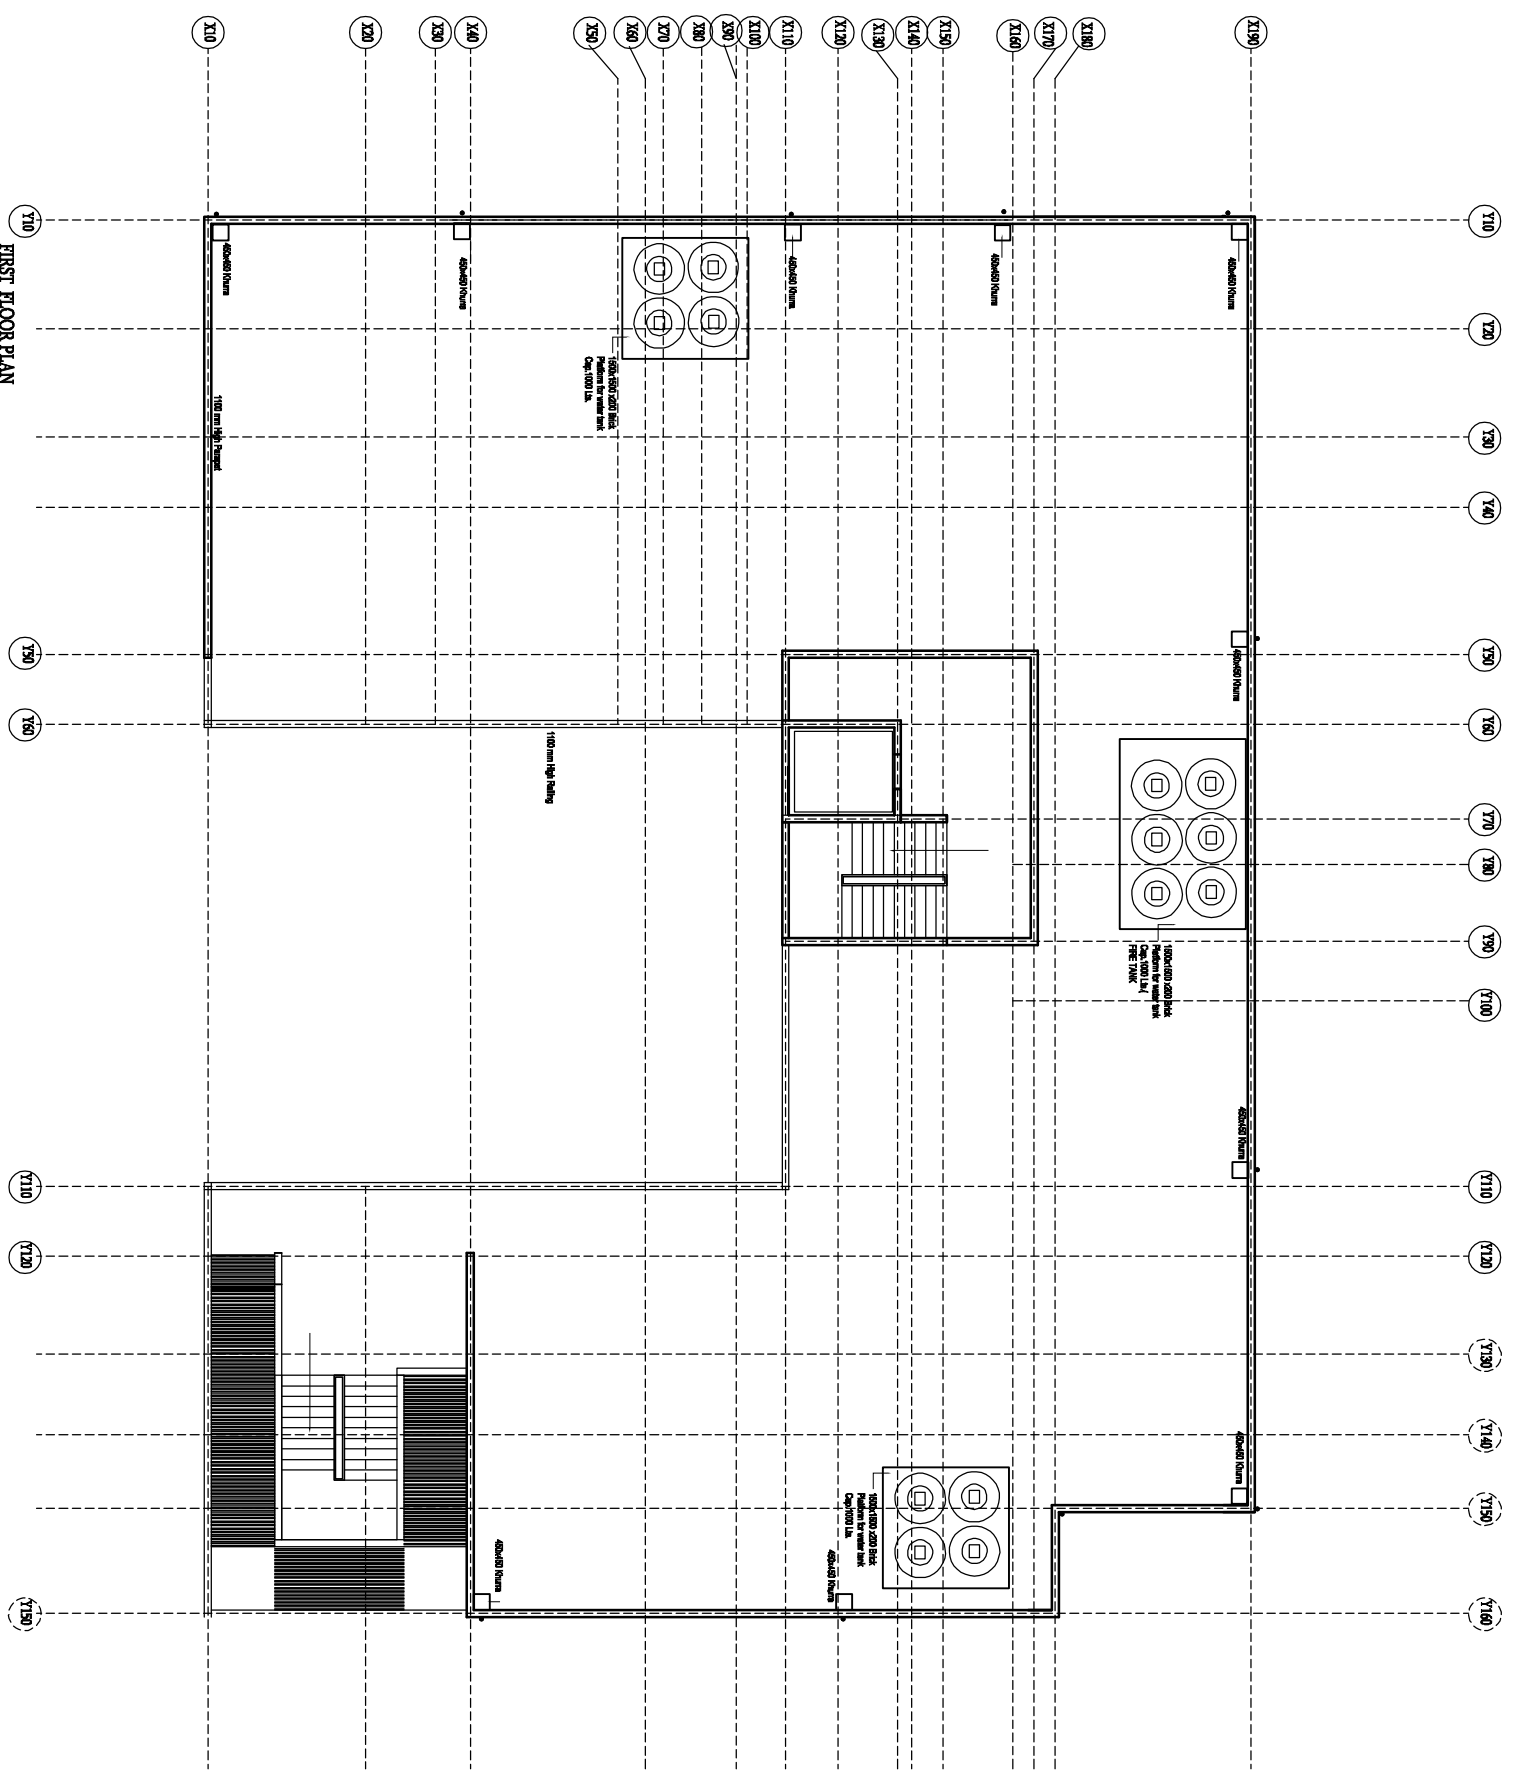

FIRST FLOOR PLAN

PROJECT

**PROPOSED DRGS. OF DEMONSTRATION HOUSING PROJECT
(Use: OLD AGE HOME) AT CHIMBEL, GOA**

DRG. TITLE

TERRACE PLAN

DATE
DEC. 2019

SCALE

NORTH

DEALT BY

APP. BY




BUILDING MATERIALS & TECHNOLOGY PROMOTION COUNCIL
MINISTRY OF HOUSING & URBAN AFFAIRS, (Govt. of India)
CORE-5A, 1st FLOOR, INDIA HABITAT CENTRE,
LODHI ROAD, NEW DELHI - 110003
PHONE-011-24638096, 011-24638097. Website: www.bmtpc.org.

DRG. NO. **2019/DHP/GA/OH/AR-04**


DRG. FOR APPROVAL TENDER CONSTRUCTION

COPYRIGHT:
 THIS DRAWING IS PROTECTED UNDER COPYRIGHT,
 NOT TO BE REPRODUCED OR COPIED TO A THIRD
 PARTY OR USED FOR ANY PURPOSE OTHER THAN
 THE PROJECT TO WHICH ISSUED WITHOUT THE
 KNOWLEDGE AND CONSENT OF THE DESIGN OFFICE

NOTES:
 * ALL DIMENSIONS ARE IN MM
 * ALL LEVELS ARE IN MM

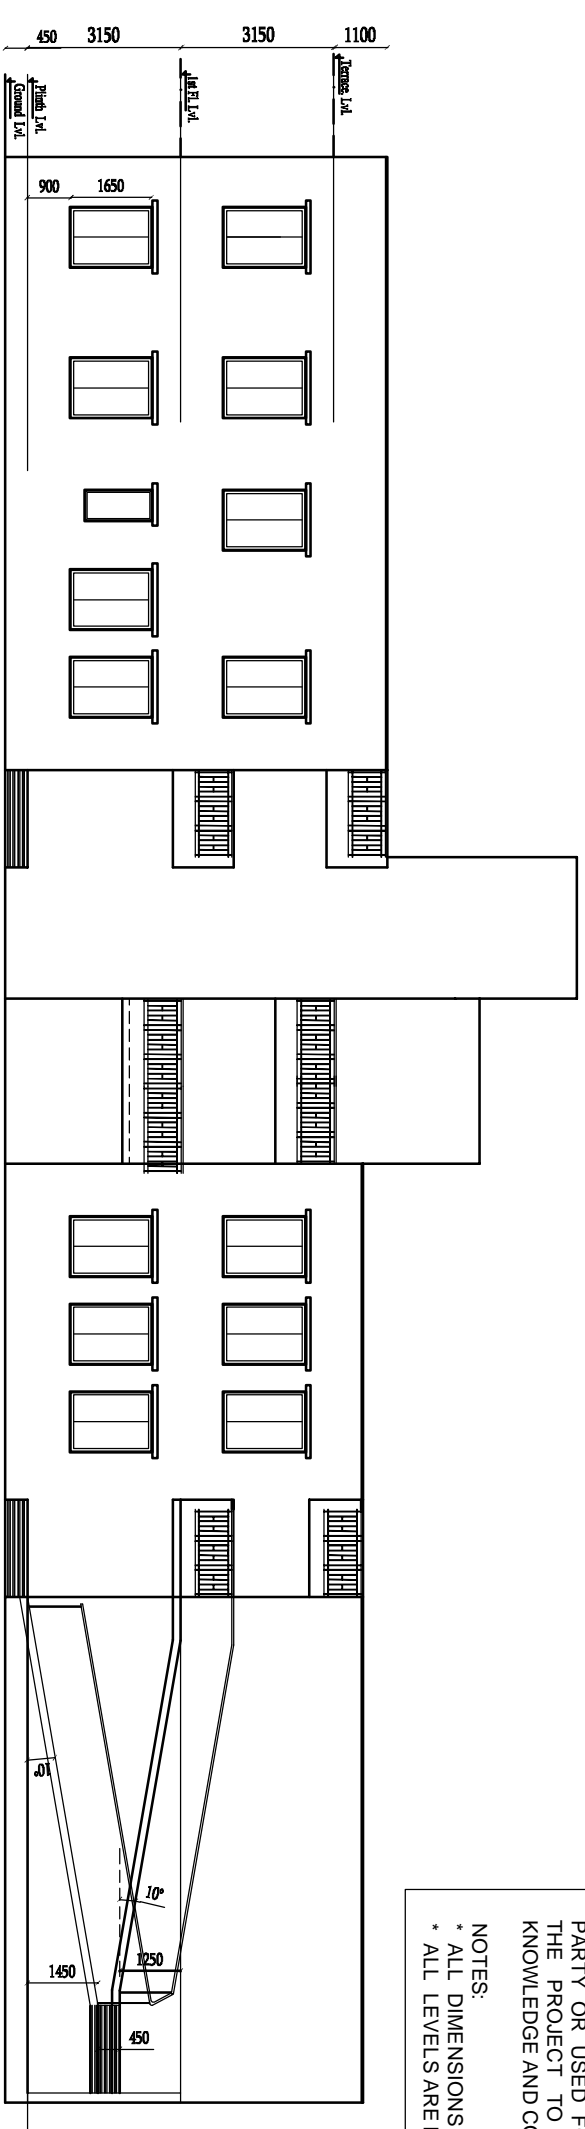

FRONT ELEVATION

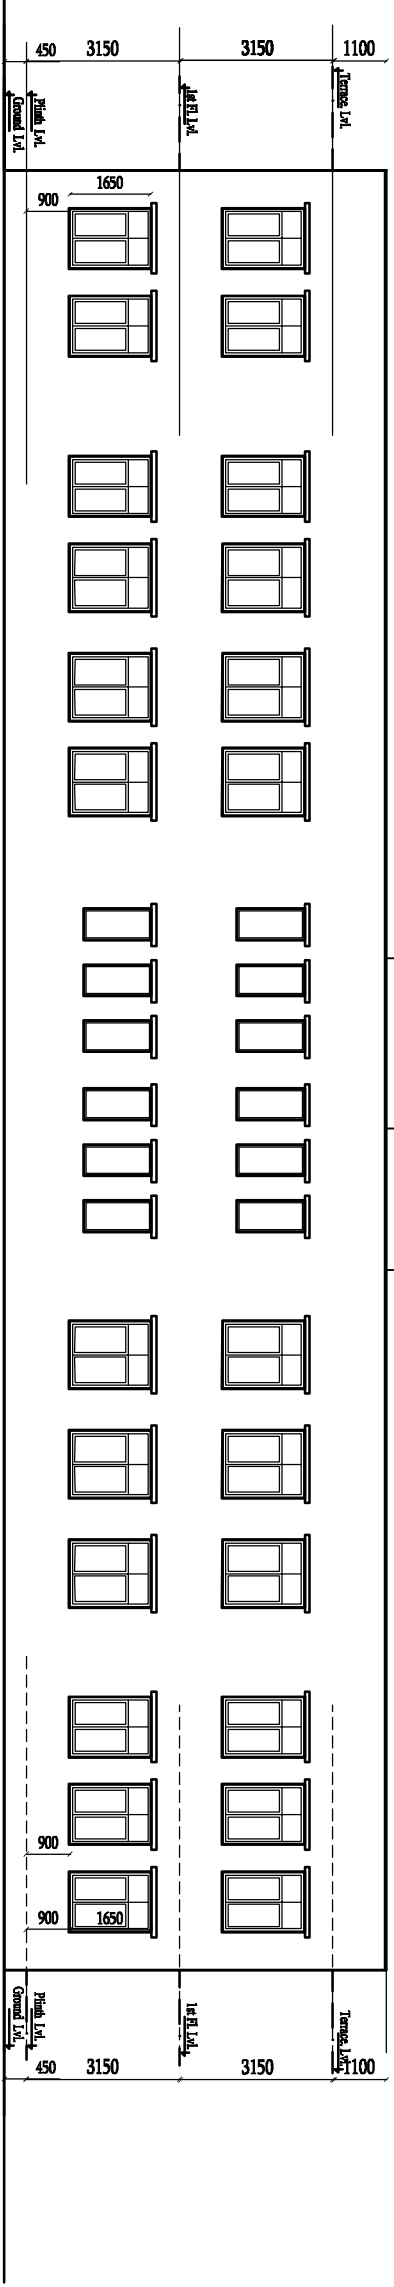

FRONT ELEVATION

PROJECT

PROPOSED DRGS. OF DEMONSTRATION HOUSING PROJECT
(Use: OLD AGE HOME) AT CHIMBEL, GOA

DRG. TITLE		ELEVATION	
DATE	SCALE	NORTH	
DEC. 2019	APP. BY		
DEALT BY			

bmtpc


BUILDING MATERIALS & TECHNOLOGY PROMOTION COUNCIL
 MINISTRY OF HOUSING & URBAN AFFAIRS, (Govt. of India)
 CORE-5A, 1st FLOOR, INDIA HABITAT CENTRE,
 LODHI ROAD, NEW DELHI -110003
 PHONE-011-24638096, 011-24638097. Website: www.bmtpc.org.

DRG. NO. **2019/DHP/GA/OH/AR-05**

DRG. FOR APPROVAL TENDER CONSTRUCTION

COPYRIGHT:
 THIS DRAWING IS PROTECTED UNDER COPYRIGHT,
 NOT TO BE REPRODUCED OR COPIED TO A THIRD
 PARTY OR USED FOR ANY PURPOSE OTHER THAN
 THE PROJECT TO WHICH ISSUED WITHOUT THE
 KNOWLEDGE AND CONSENT OF THE DESIGN OFFICE

NOTES:
 * ALL DIMENSIONS ARE IN MM
 * ALL LEVELS ARE IN MM

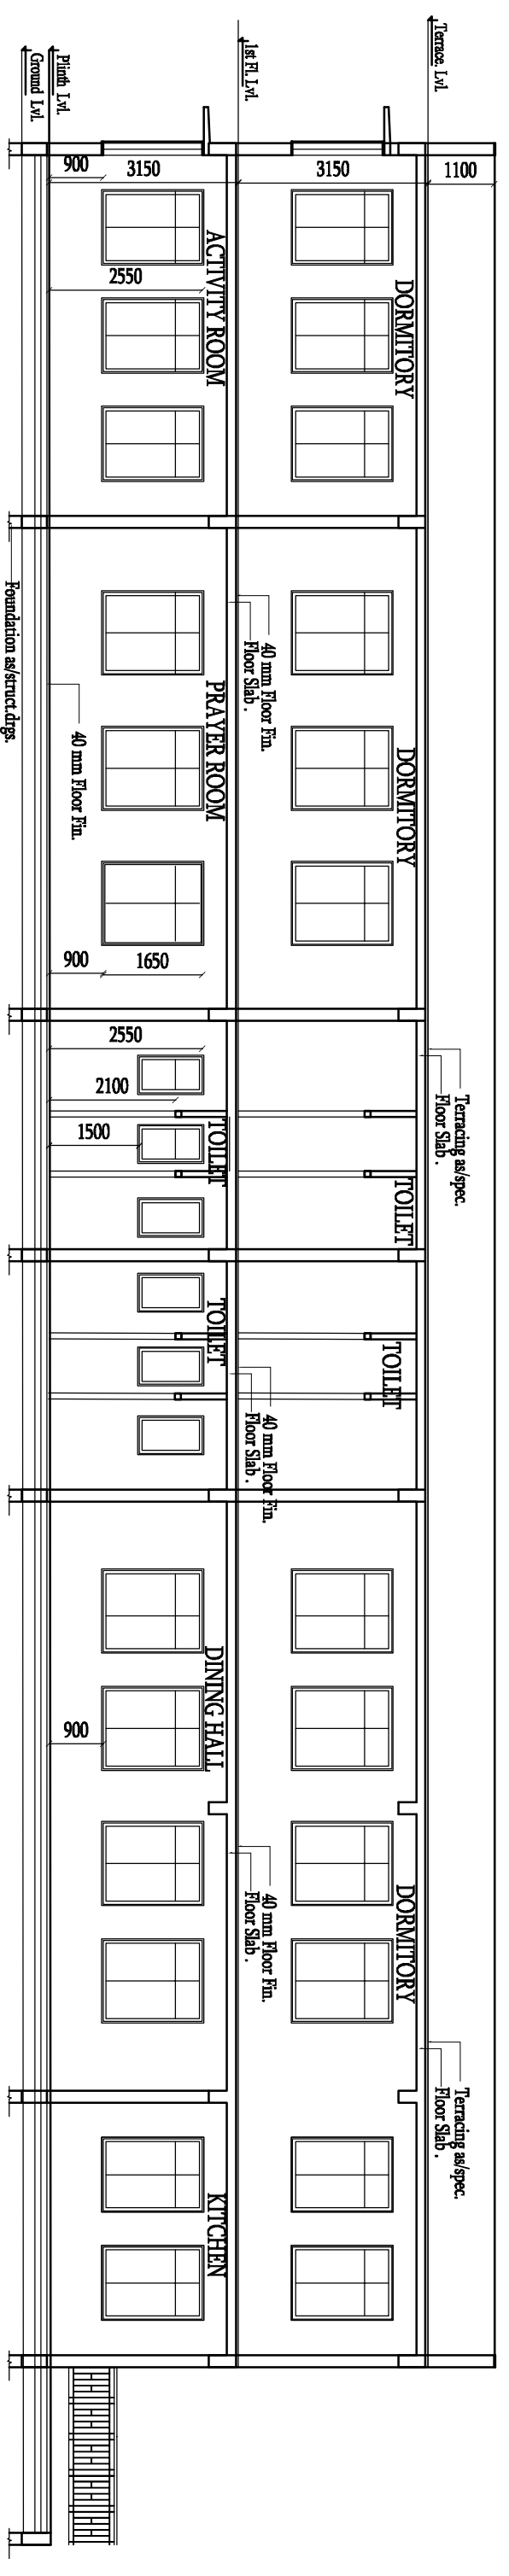


SECTION

PROJECT		DRG. TITLE		SECTION	
<p>PROPOSED DRGS. OF DEMONSTRATION HOUSING PROJECT (Use: OLD AGE HOME) AT CHIMBEL, GOA</p>		<p>SECTION</p>		<p>SECTION</p>	
DATE	DEC. 2019	SCALE	NORTH	<p>BUILDING MATERIALS & TECHNOLOGY PROMOTION COUNCIL MINISTRY OF HOUSING & URBAN AFFAIRS, (Govt. of India) CORE-5A, 1st FLOOR, INDIA HABITAT CENTRE, LODHI ROAD, NEW DELHI -110003 PHONE-011-24638096, 011-24638097. Website: www.bmtpc.org.</p>	
DEALT BY	APP. BY	DRG. NO.		<p>2019/DHP/GA/OH/AR-06</p>	
<p>DRG. FOR <input type="checkbox"/> APPROVAL <input checked="" type="checkbox"/> TENDER <input type="checkbox"/> CONSTRUCTION</p>					

COPYRIGHT:
THIS DRAWING IS PROTECTED UNDER COPYRIGHT,
NOT TO BE REPRODUCED OR COPIED TO A THIRD
PARTY OR USED FOR ANY PURPOSE OTHER THAN
THE PROJECT TO WHICH ISSUED WITHOUT THE
KNOWLEDGE AND CONSENT OF THE DESIGN OFFICE

NOTES:
* ALL DIMENSIONS ARE IN MM
* ALL LEVELS ARE IN MM

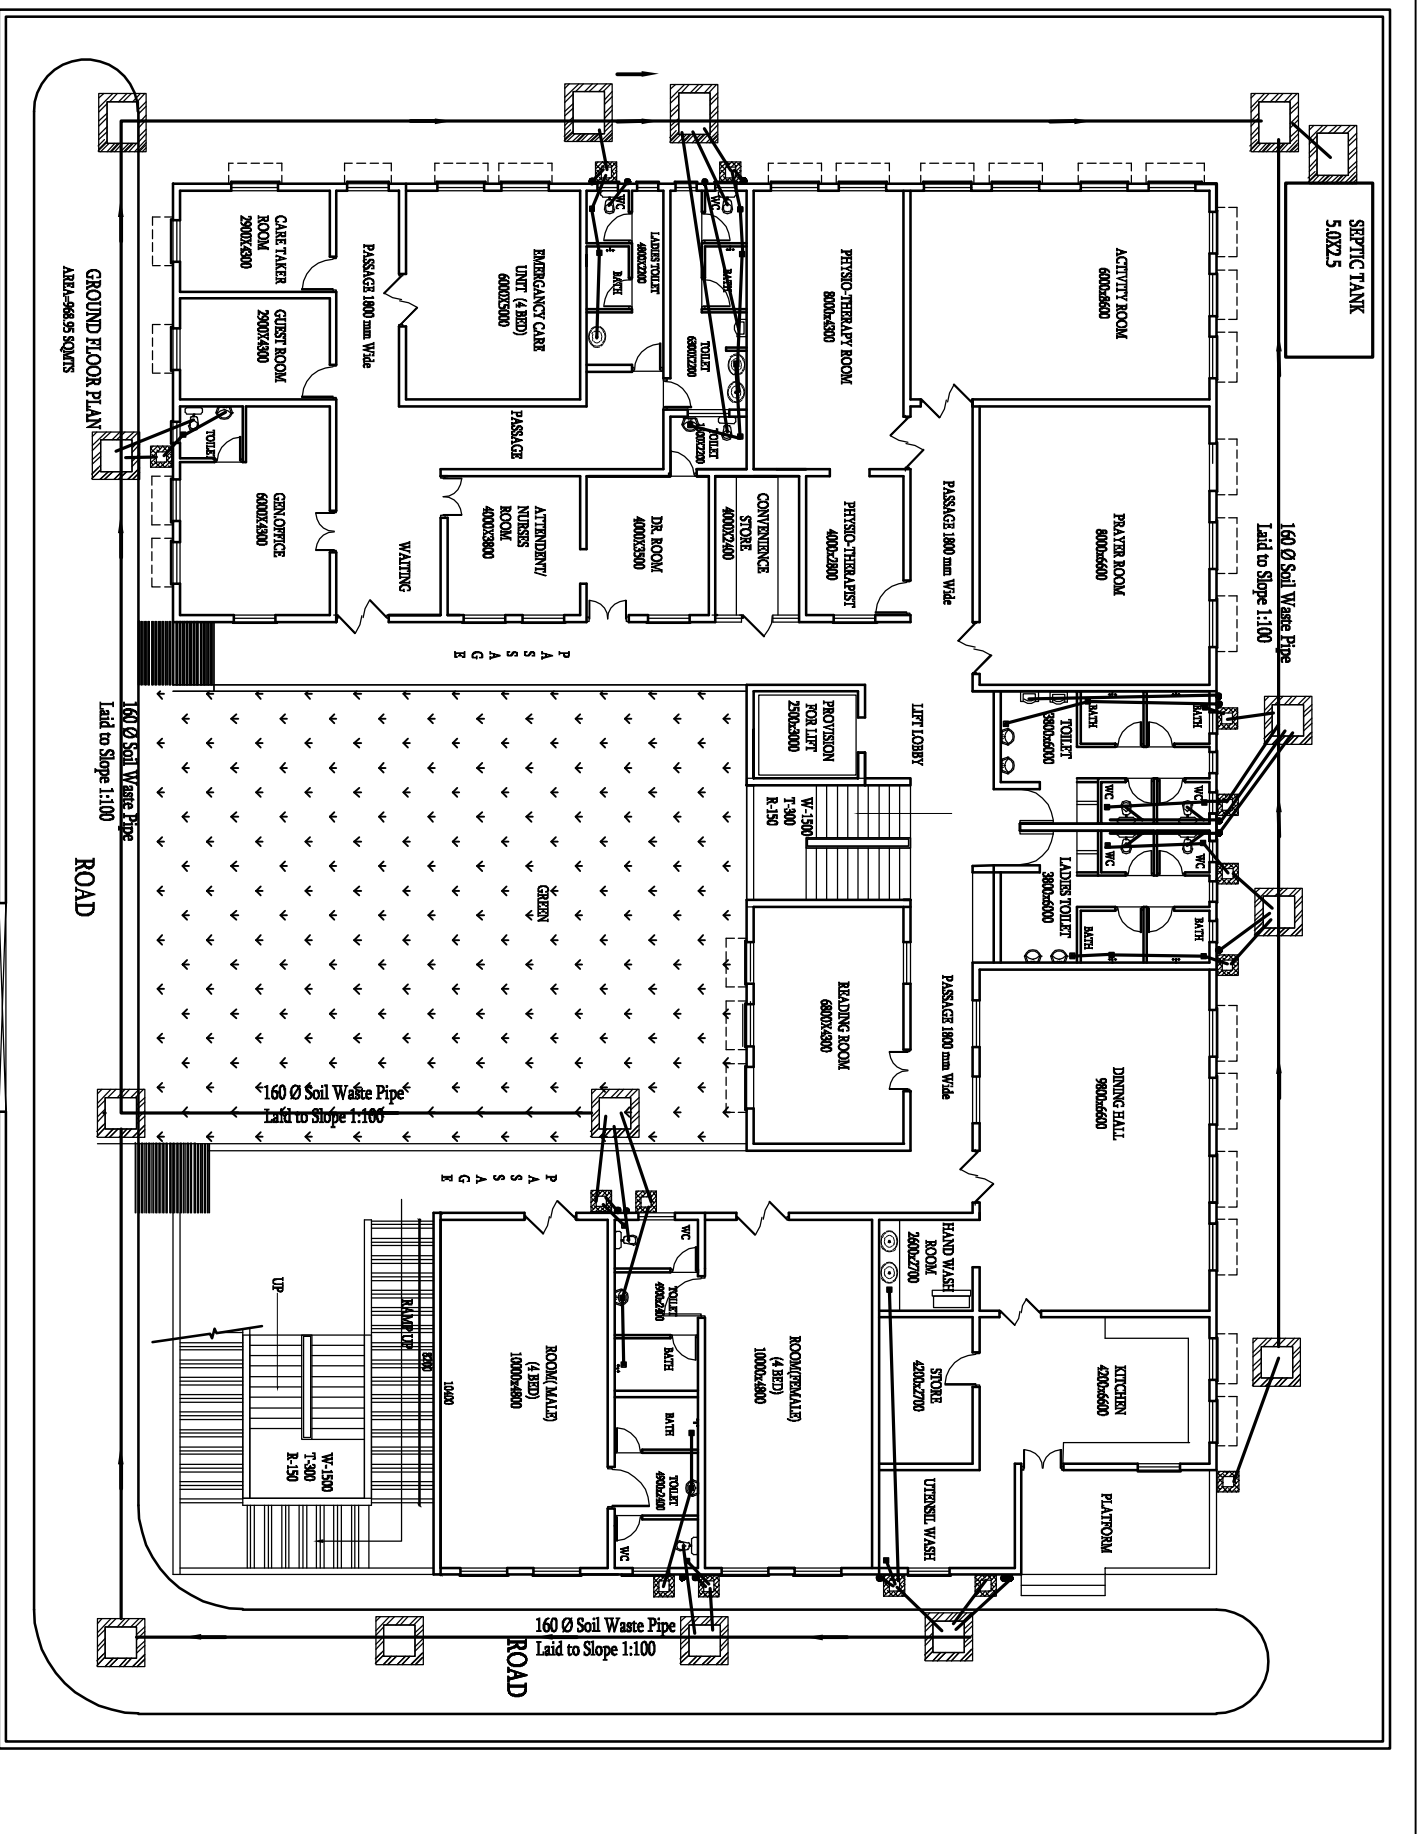

LAYOUT PLAN
SEWEWAGE PLAN

PROJECT

PROPOSED DRGS. OF DEMONSTRATION HOUSING PROJECT
(Use: OLD AGE HOME) AT CHIMBEL, GOA

DRG. TITLE

**LAYOUT PLAN
SEWEWAGE PLAN**


DATE

DEC. 2019

SCALE

APP. BY

 NORTH



DMPC
BUILDING MATERIALS & TECHNOLOGY PROMOTION COUNCIL
MINISTRY OF HOUSING & URBAN AFFAIRS, (Govt of India)
CORE-5A, 1st FLOOR, INDIA HABITAT CENTRE,
LODHI ROAD, NEW DELHI - 110003
PHONE-011-24638096, 011-24638097. Website: www.dmtpc.org.

DRG. NO.

2019/DHP/GA/OH/AR-07

DRG. FOR

APPROVAL


TENDER

CONSTRUCTION

COPYRIGHT:
THIS DRAWING IS PROTECTED UNDER COPYRIGHT.
NOT TO BE REPRODUCED OR COPIED TO A THIRD
PARTY OR USED FOR ANY PURPOSE OTHER THAN
THE PROJECT TO WHICH ISSUED WITHOUT THE
KNOWLEDGE AND CONSENT OF THE DESIGN OFFICE

NOTES:
* ALL DIMENSIONS ARE IN MM
* ALL LEVELS ARE IN MM

--- WATER SUPPLY LINE
SV SLUICE VALVE

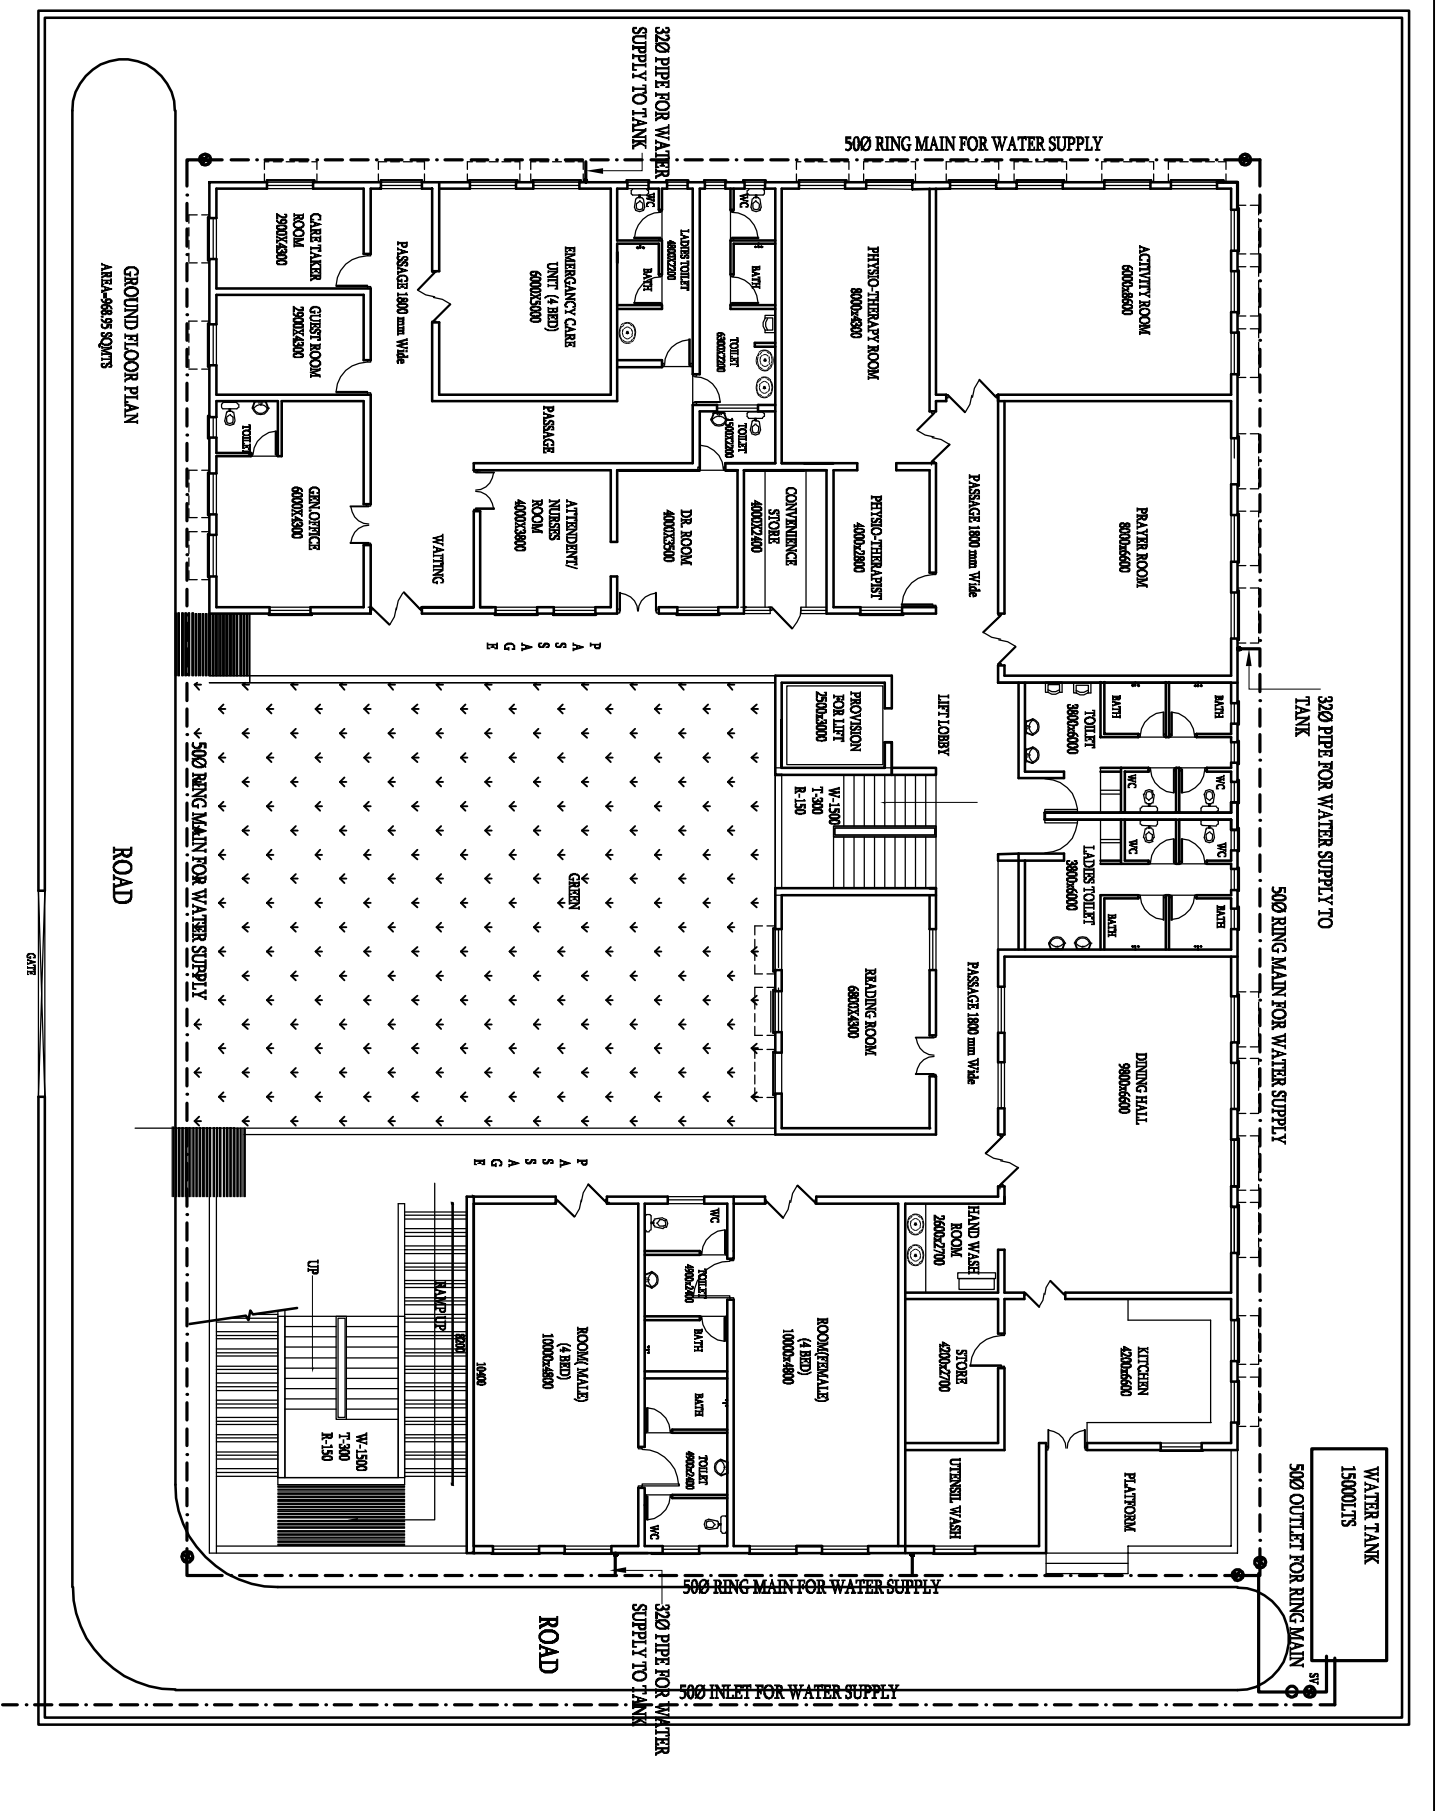

LAYOUT PLAN
WATER SUPPLY

PROJECT

**PROPOSED DRGS. OF DEMONSTRATION HOUSING PROJECT
(USE: OLD AGE HOME) AT CHIMBEL, GOA**

DRG. TITLE

**LAYOUT PLAN
WATER SUPPLY**


DATE

DEC. 2019

SCALE

APP. BY

 NORTH



BUILDING MATERIALS & TECHNOLOGY PROMOTION COUNCIL
MINISTRY OF HOUSING & URBAN AFFAIRS, (Govt. of India)
CORE-5A, 1st FLOOR, INDIA HABITAT CENTRE,
LODHI ROAD, NEW DELHI - 110003
PHONE-011-24638096, 011-24638097. Website: www.dmpc.org.

DRG. NO. **2019/DHP/GA/OH/AR-08**


DRG. FOR APPROVAL TENDER CONSTRUCTION

COPYRIGHT:
THIS DRAWING IS PROTECTED UNDER COPYRIGHT.
NOT TO BE REPRODUCED OR COPIED TO A THIRD
PARTY OR USED FOR ANY PURPOSE OTHER THAN
THE PROJECT TO WHICH ISSUED WITHOUT THE
KNOWLEDGE AND CONSENT OF THE DESIGN OFFICE

NOTES:
* ALL DIMENSIONS ARE IN MM
* ALL LEVELS ARE IN MM

LEGEND

- RAIN WATER CHAMBER
- - - DRAINAGE PIPE

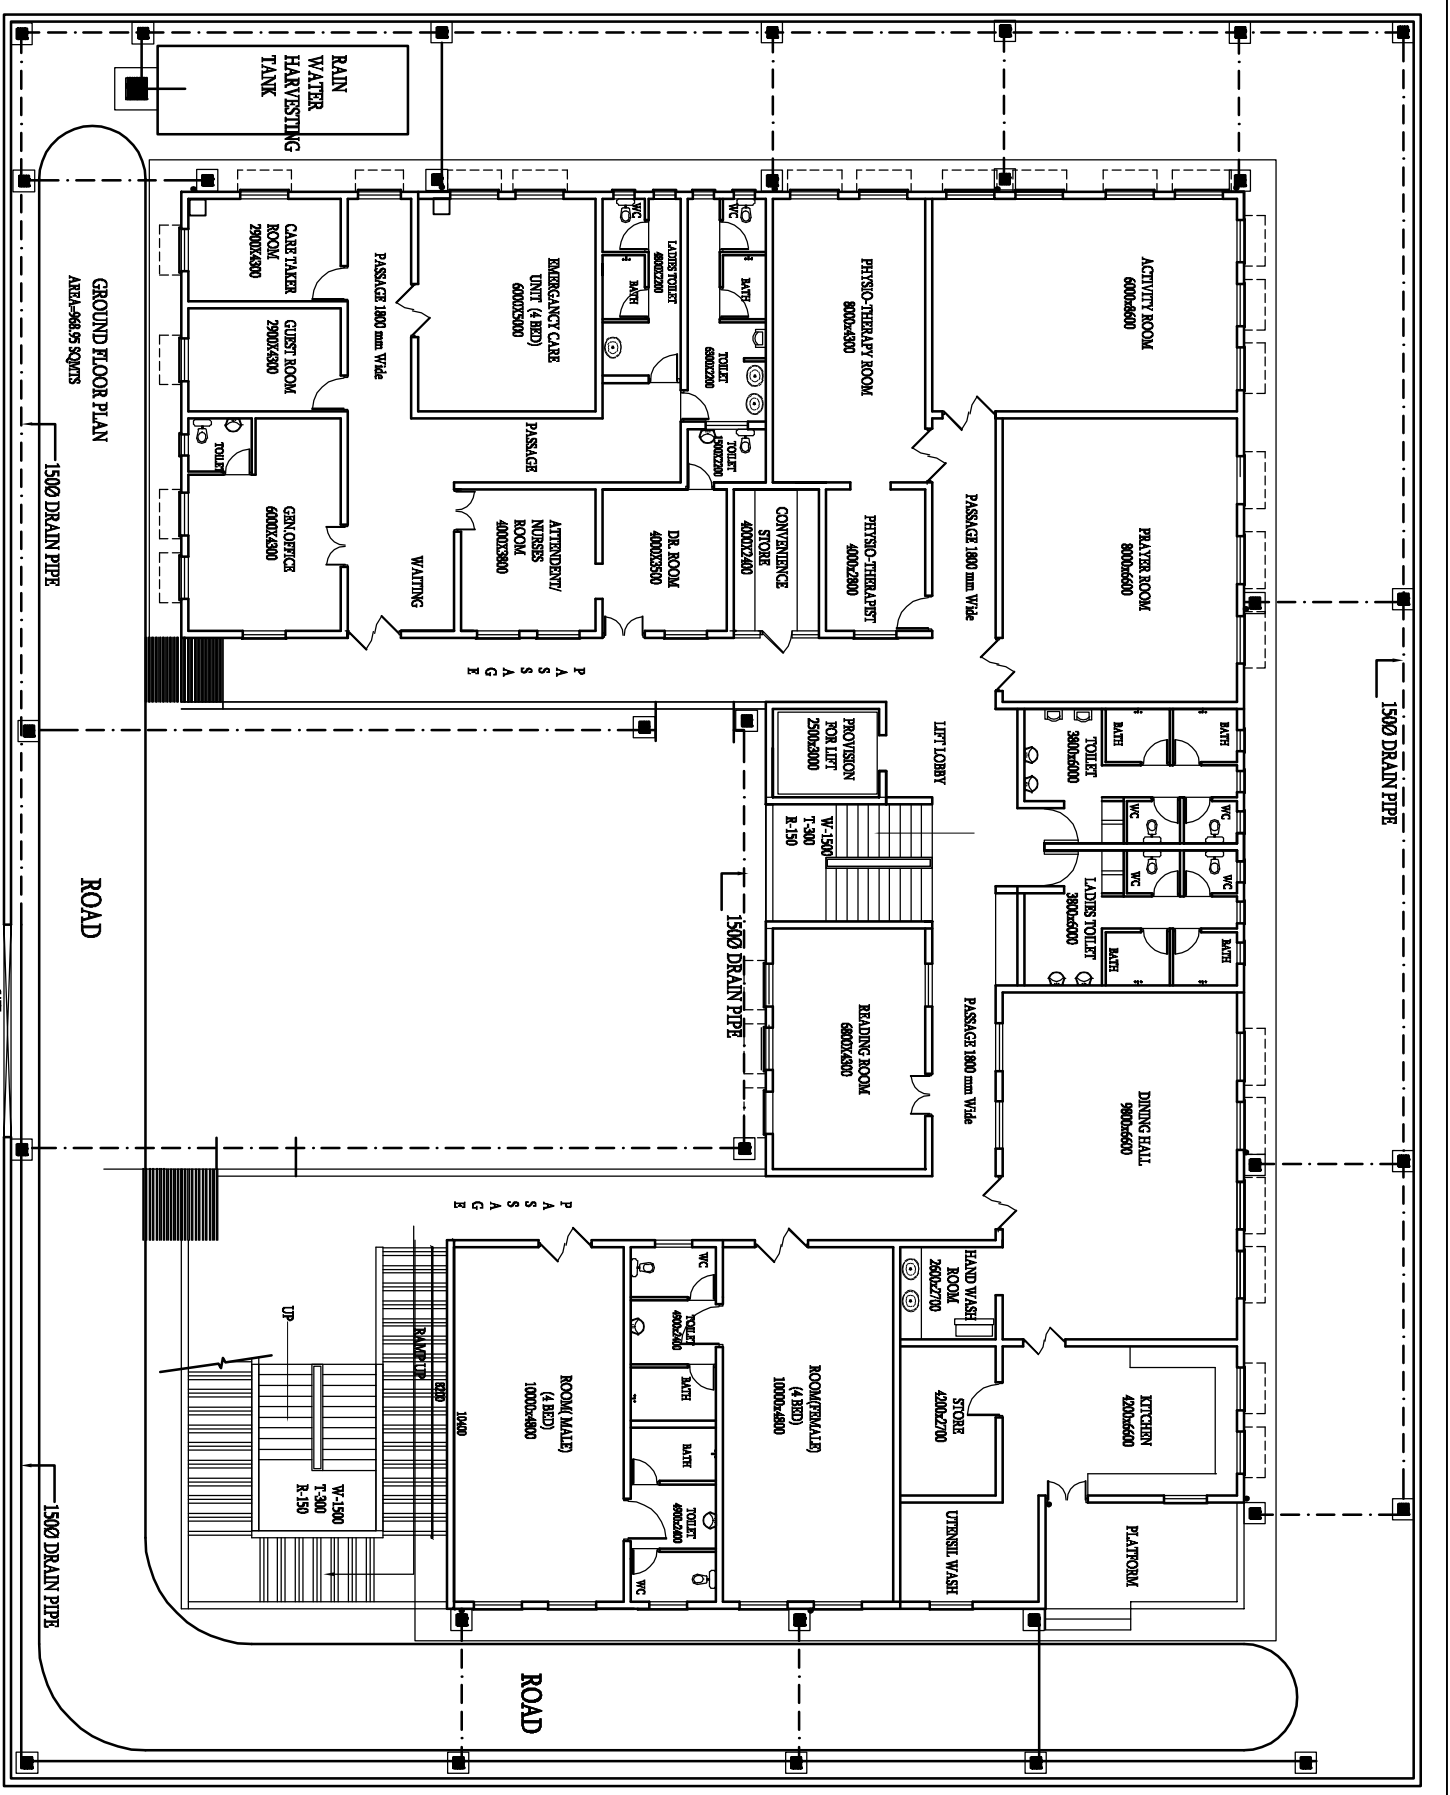


LAYOUT PLAN
DRAINAGE

PROJECT

**PROPOSED DRGS. OF DEMONSTRATION HOUSING PROJECT
(Use: OLD AGE HOME) AT CHIMBEL, GOA**

DRG. TITLE
**LAYOUT PLAN
DRAINAGE**

DATE DEC. 2019	SCALE	NORTH
DEALT BY	APP. BY	

 


BUILDING MATERIALS & TECHNOLOGY PROMOTION COUNCIL
MINISTRY OF HOUSING & URBAN AFFAIRS, (Govt. of India)
CORE-5A, 1st FLOOR, INDIA HABITAT CENTRE,
LODHI ROAD, NEW DELHI - 110003
PHONE-011-24638096, 011-24638097. Website: www.bmtgc.org.

DRG. NO. **2019/DHP/GA/OH/AR-09**

DRG. FOR APPROVAL TENDER CONSTRUCTION

COPYRIGHT:
THIS DRAWING IS PROTECTED UNDER COPYRIGHT.
NOT TO BE REPRODUCED OR COPIED TO A THIRD
PARTY OR USED FOR ANY PURPOSE OTHER THAN
THE PROJECT TO WHICH ISSUED WITHOUT THE
KNOWLEDGE AND CONSENT OF THE DESIGN OFFICE

NOTES:
* ALL DIMENSIONS ARE IN MM
* ALL LEVELS ARE IN MM

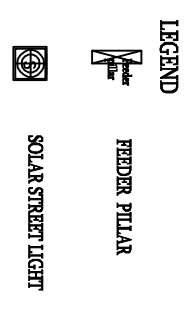

PROJECT

**PROPOSED DRGS. OF DEMONSTRATION HOUSING PROJECT
(Use: OLD AGE HOME) AT CHIMBEL, GOA**

DRG.TITLE		NORTH
LAYOUT PLAN EXT. ELECTRICAL PLAN		
DATE	SCALE	
DEC. 2019	APP. BY	
DEALT BY		

bmtpc

BUILDING MATERIALS & TECHNOLOGY PROMOTION COUNCIL
MINISTRY OF HOUSING & URBAN AFFAIRS, (Govt. of India)
CORE-5A, 1st FLOOR, INDIA HABITAT CENTRE,
LODHI ROAD, NEW DELHI - 110003
PHONE-011-24638096, 011-24638097. Website: www.bmtpc.org.

DRG.NO. **2019/DHP/GA/OH/AR-10**

DRG.FOR APPROVAL TENDER CONSTRUCTION